

- D1 Steel Security Door: W900mm*H2080mm
- D2 Sandwich Panel Door:W700*H2000mm
- W1 PVC Double-glazed Sliding Window with Roller Shutter:W800mm*H1100mm
- W2 PVC Double-glazed Sliding Window(Embossed Glass):W800mm*H400mm
- W3 PVC Double-glazed Fixed Window:W2350mm*H2300mm(with installation frame)

S1 Exhaust Fan:250*250mm(with PVC frame)

Flooring Fiber Cement Board+PVC Flooring



Outer Wall Panel 100mm Rock Wool(120kg/m³)Sandwich Panel, double sides 0.45mm Color Steel Sheet(white-grey)

Inner Wall Panel 50mm Rock Wool(120kg/m³) Sandwich Panel, double sides 0.45mm Color Steel Sheet(white-grey)




Zhejiang Putian integrated housing Co.,Ltd.
Hangzhou Zhongpu Architecture Design (institute)Co.,Ltd.

Project name 工程名称	Project No. 工程编号 PTM2C331	Designer 设计师 周天航	Drawer 制图员 周天航	Assessor 审核 周志委	Page 图号 01
Triple Unit	Item 图纸名称 plan	Category 设计阶段 PROPOSAL	Proofreader 校对 MZ	Date 日期 2014.12.08	Proportion 比例 1:60

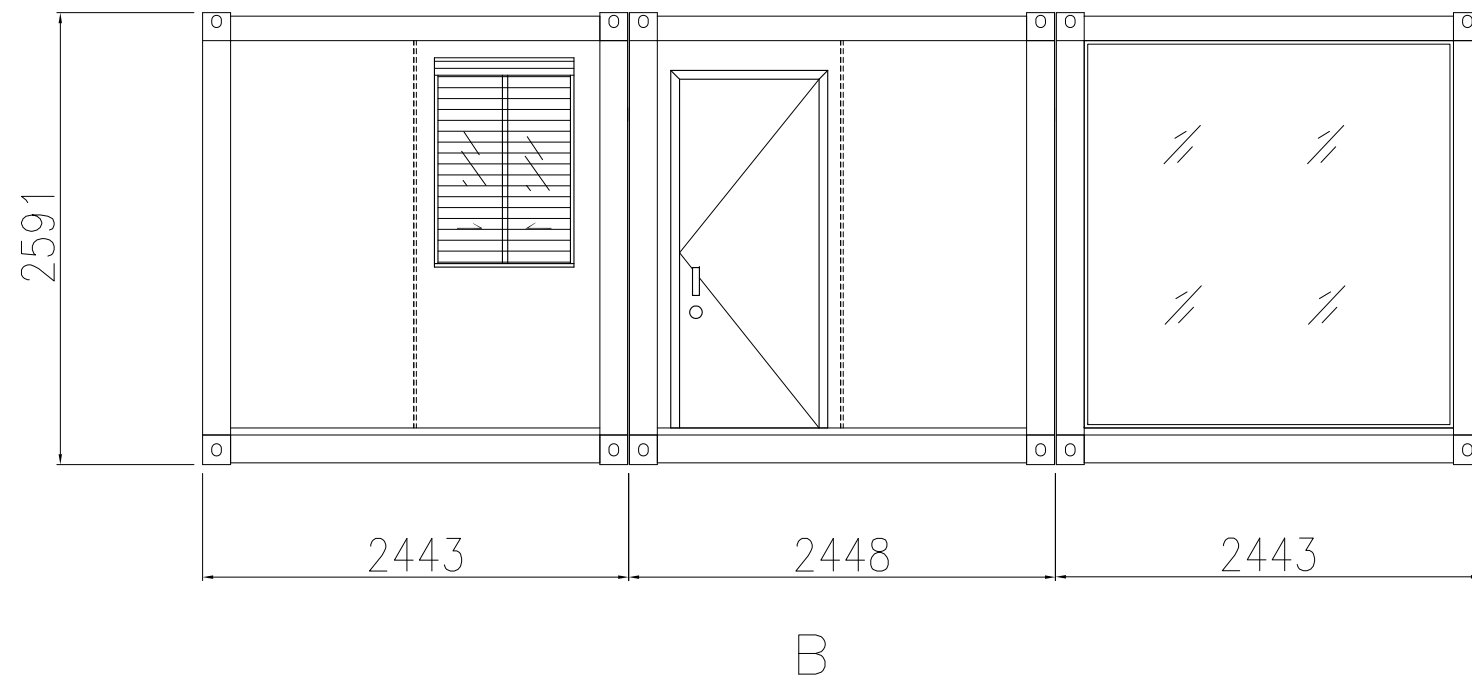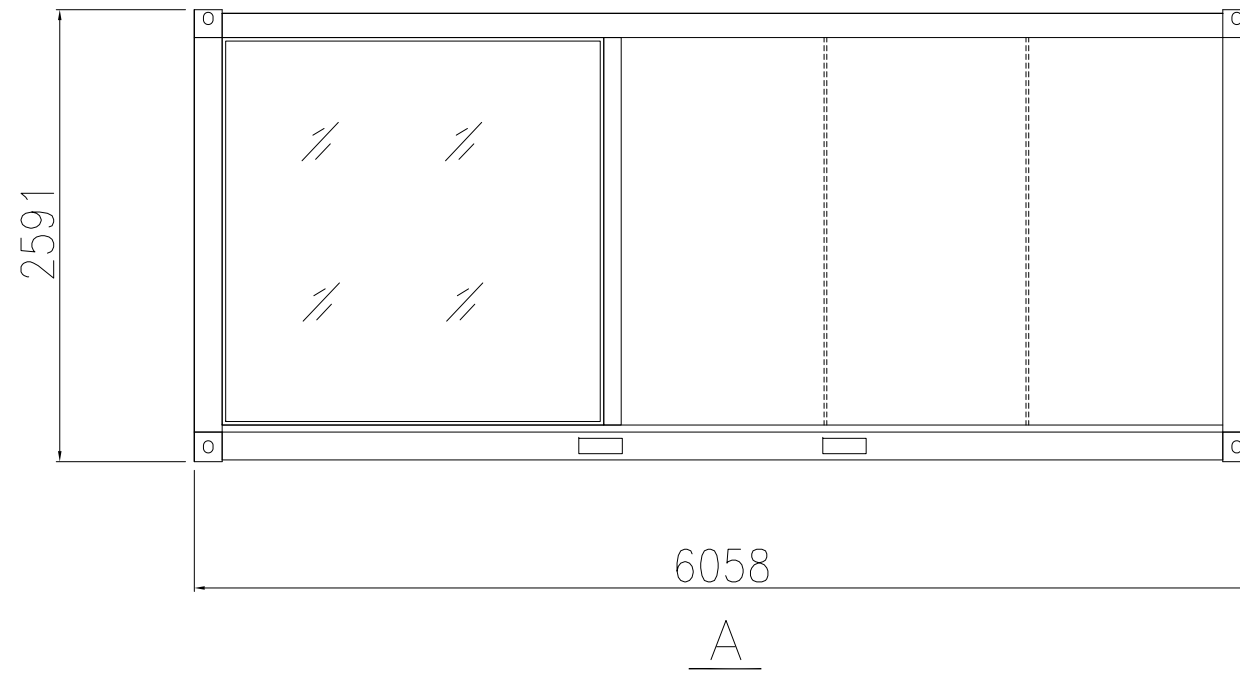


Zhejiang Putian integrated housing Co.,Ltd.
 Hangzhou Zhongpu Architecture Design (institute)Co.,Ltd.

Project name 工程名称	Project No. 工程编号 PTM2C331	Designer 设计师 周天航	Drawer 制图员 周天航	Assessor 审核 周志委	Page 图号 02
Triple Unit	Item 图纸名称 Elevation	Category 设计阶段 PROPOSAL	Proofreader 校对 MZ	Date 日期 2014.12.08	Proportion 比例 1:60

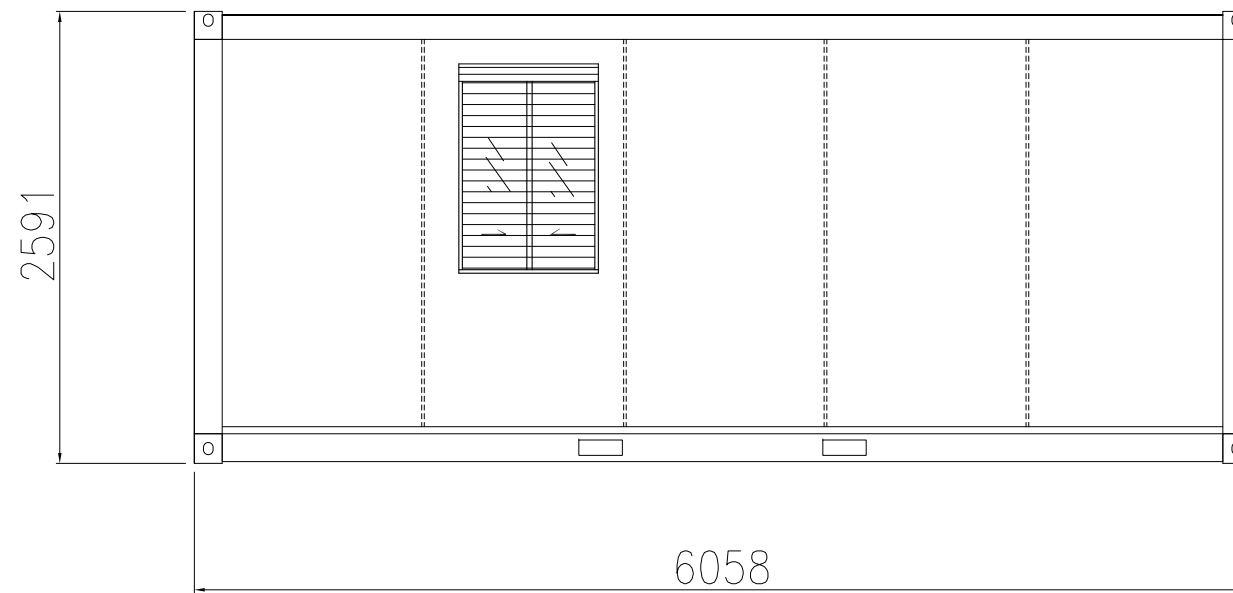

C

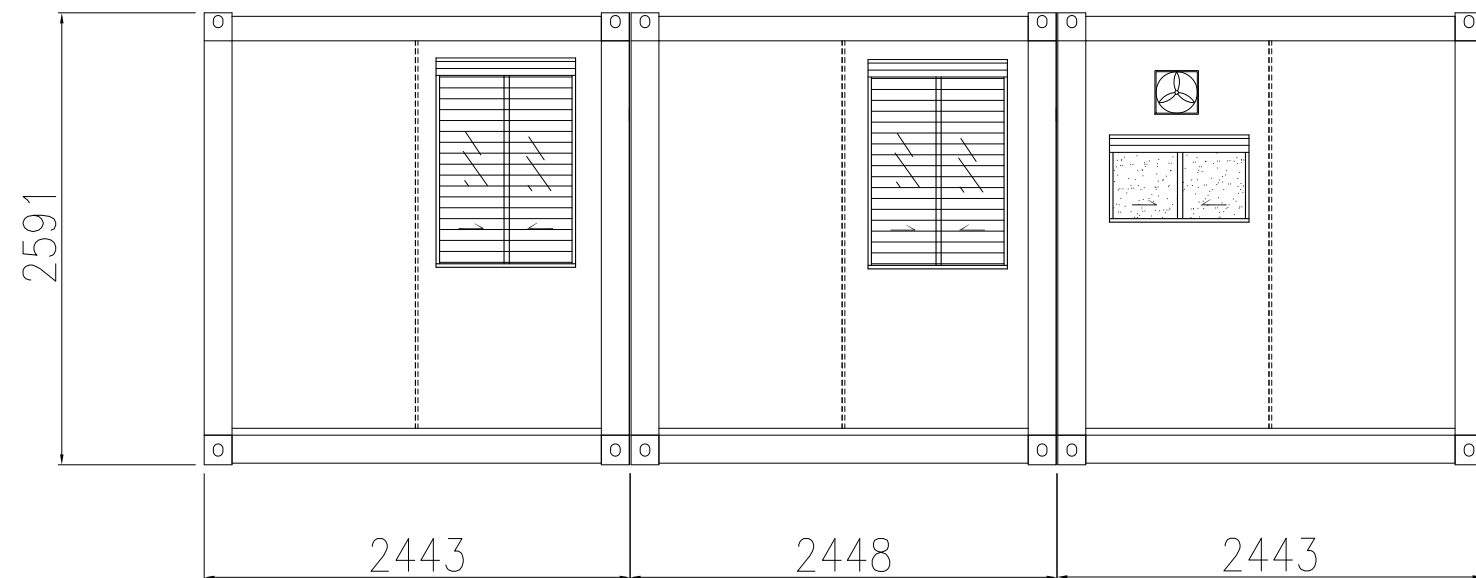


D



 

 


Zhejiang Putian integrated housing Co.,ltd.
Hangzhou Zhongpu Architecture Design (institute)Co.,ltd.

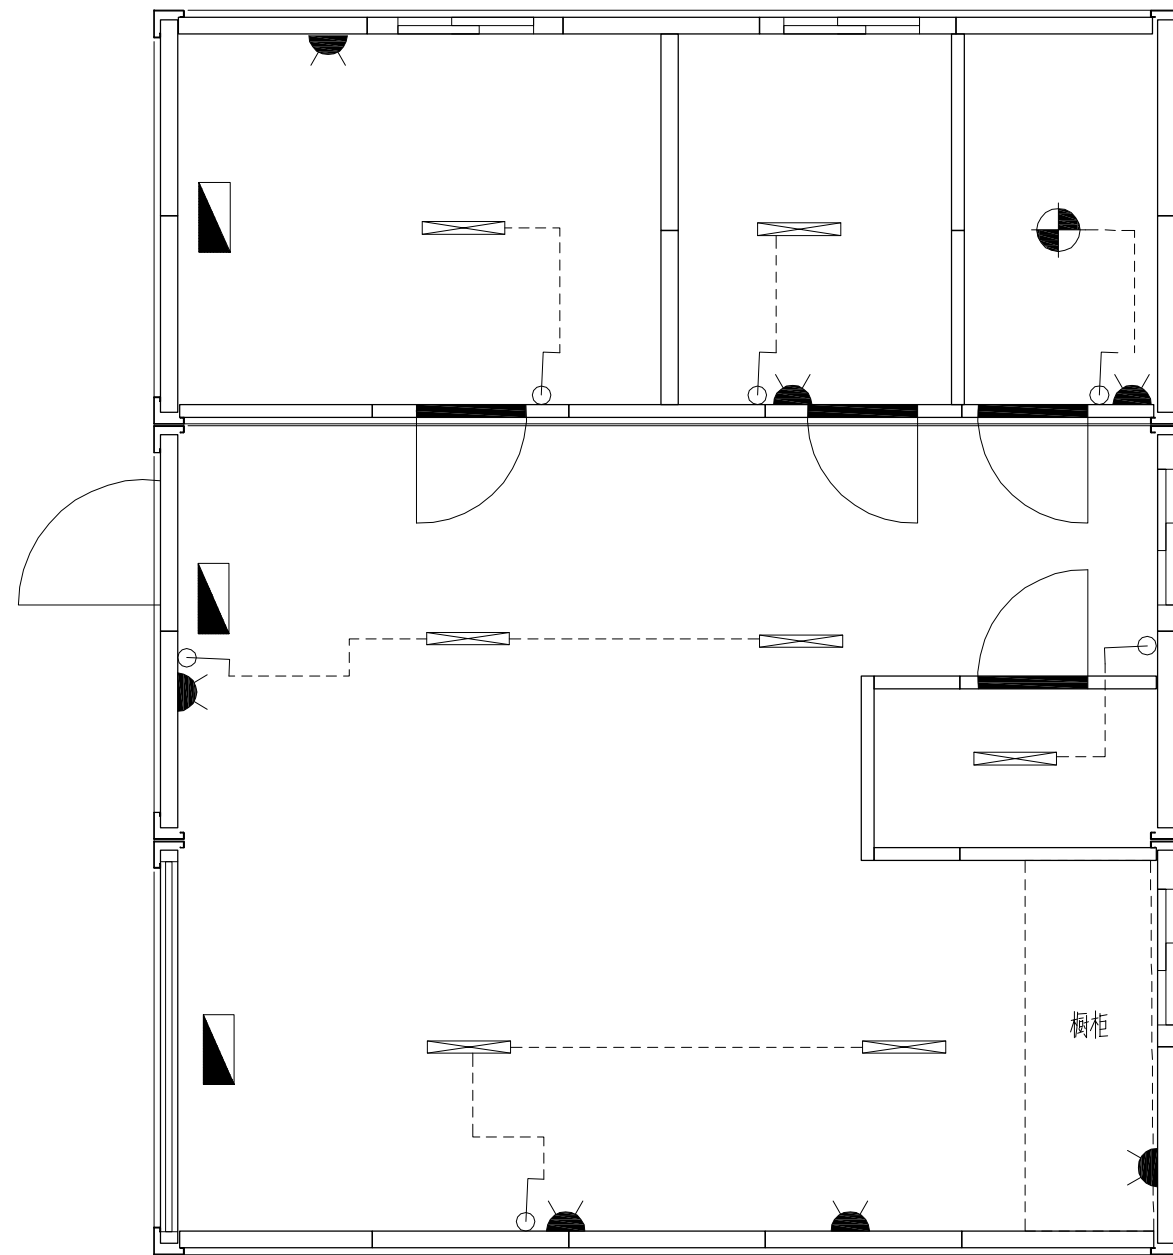
Project name 工程名称	Project No. 工程编号 PTM2C331	Designer 设计师 周天航	Drawer 制图员 周天航	Assessor 审核 周志委	Page 图号 03
Triple Unit	Item 图纸名称 Elevation	Category 设计阶段 PROPOSAL	Proofreader 校对 MZ	Date 日期 2014.12.08	Proportion 比例 1:60



 Position Height of Switch :H=1200mm

 Position Height of Socket: H=300mm

Legend	Name	Specification
	Single-tube Daylight Lamp	
	Ceiling Lamp	
	One-way Switch	
	Distribution Box	
	Socket	

		Zhejiang Putian integrated housing Co.,Ltd. Hangzhou Zhongpu Architecture Design (institute)Co.,Ltd.			
Project name 工程名称	Project No. 工程编号	Designer 设计师	Drawer 制图员	Assessor 审核	Page 图号
Triple Unit		周天航	周天航	周志委	04
Item 图纸名称	Category 设计阶段	Proofreader 校对	Date 日期	Proportion 比例	
Electrical Plan	PROPOSA	业务员	2014.12.08	1:60	