

电力	暖通	动力
建筑	结构	给排水
会	签	

PT221046-1

General information:

Detachable containers, size 6058×3025×2791mm, Qty: 7units

Loading parameters:

Wind load : 120km/h

Snow load: 1.00kN/m²

Floor live load: 2.50kN/m²

Material specifications:

1. Frame: All profiles are SGH440 high-strength galvanized, powder sprayed and painted. 9PCS bottom secondary beams, no forklift beam, column thickness 3.0mm. The frame is delivered in bulk, installed on site, RAL9003.

2. Roof: 70mm rock wool sandwich panel roof, density 100kg/m³, Upper/lower panel 0.4mm steel plate (color steel plate is AZM100g/m²+PE20/5um)

3. Exterior wall panel: 75mm EPS sandwich panel wall, density 12kg/m³, steel plate panel thickness 0.40mm, AZM100g/m²+PE20/5um. Wall panel color RAL9003.

4. Floor: 1.8mm PVC wood grain floor+18mm cement fiber board.

5. Door: D1: 920x2035mm steel door (1 set)



Socket

Switch

Window: W1: 930x1100mm PVC single glass movable window+screen window (2 sets, 950mm above the ground)

6. Power standard: Australian standard power 240V, 2 lamps, 1 switch, 2 Australian standard double plugs, 1 distribution box.

Copyright 2016.
 本图版权归浙江普天集成房屋有限公司所有，除本工程外对本图的任何其它用途和复制，
 必须获得本公司书面许可。
 THE OWNERSHIP OF THE COPYRIGHT IN THIS DRAWING IS RETAINED BY
 ZHEJIANG PUTIAN INTEGRATED HOUSING CO.LTD. WRITTEN CONSENT MUST BE
 OBTAINED BEFORE ANY USE OR REPRODUCTION OF THE DRAWING.

版本	修改内容	日期	发布人
Rev.	Description	Date	who send



Zhejiang Putian integrated housing Co., Ltd.
 Hangzhou Zhongpu Architecture Design (institute) Co., Ltd.

证书等级

证书编号

合作设计单位
 Cooperative Designer

工序	签名	日期
Process	Signature	Date

审定		
Authorized By		

审核		
Verified By		

项目负责人		
Process		

校对		
Checked By		

设计	LHB	
Designed By		

制图	LHB	
Drawn By		

执业签章	
Engineer Signature	

出图签章	
Engineer Signature	

项目名称	澳大利亚-集装箱
Project Name	


图名	设计说明
Title	

工程编号	PT221046-1	专业	JZ
Code		Spec	

比例		图号	J0-0
Scale		Fig No	

未盖技术出图章 本图纸无效
 This drawing is void only after being stamped and released by the client.

电力	暖通	动力
建筑	结构	给排水
会签		

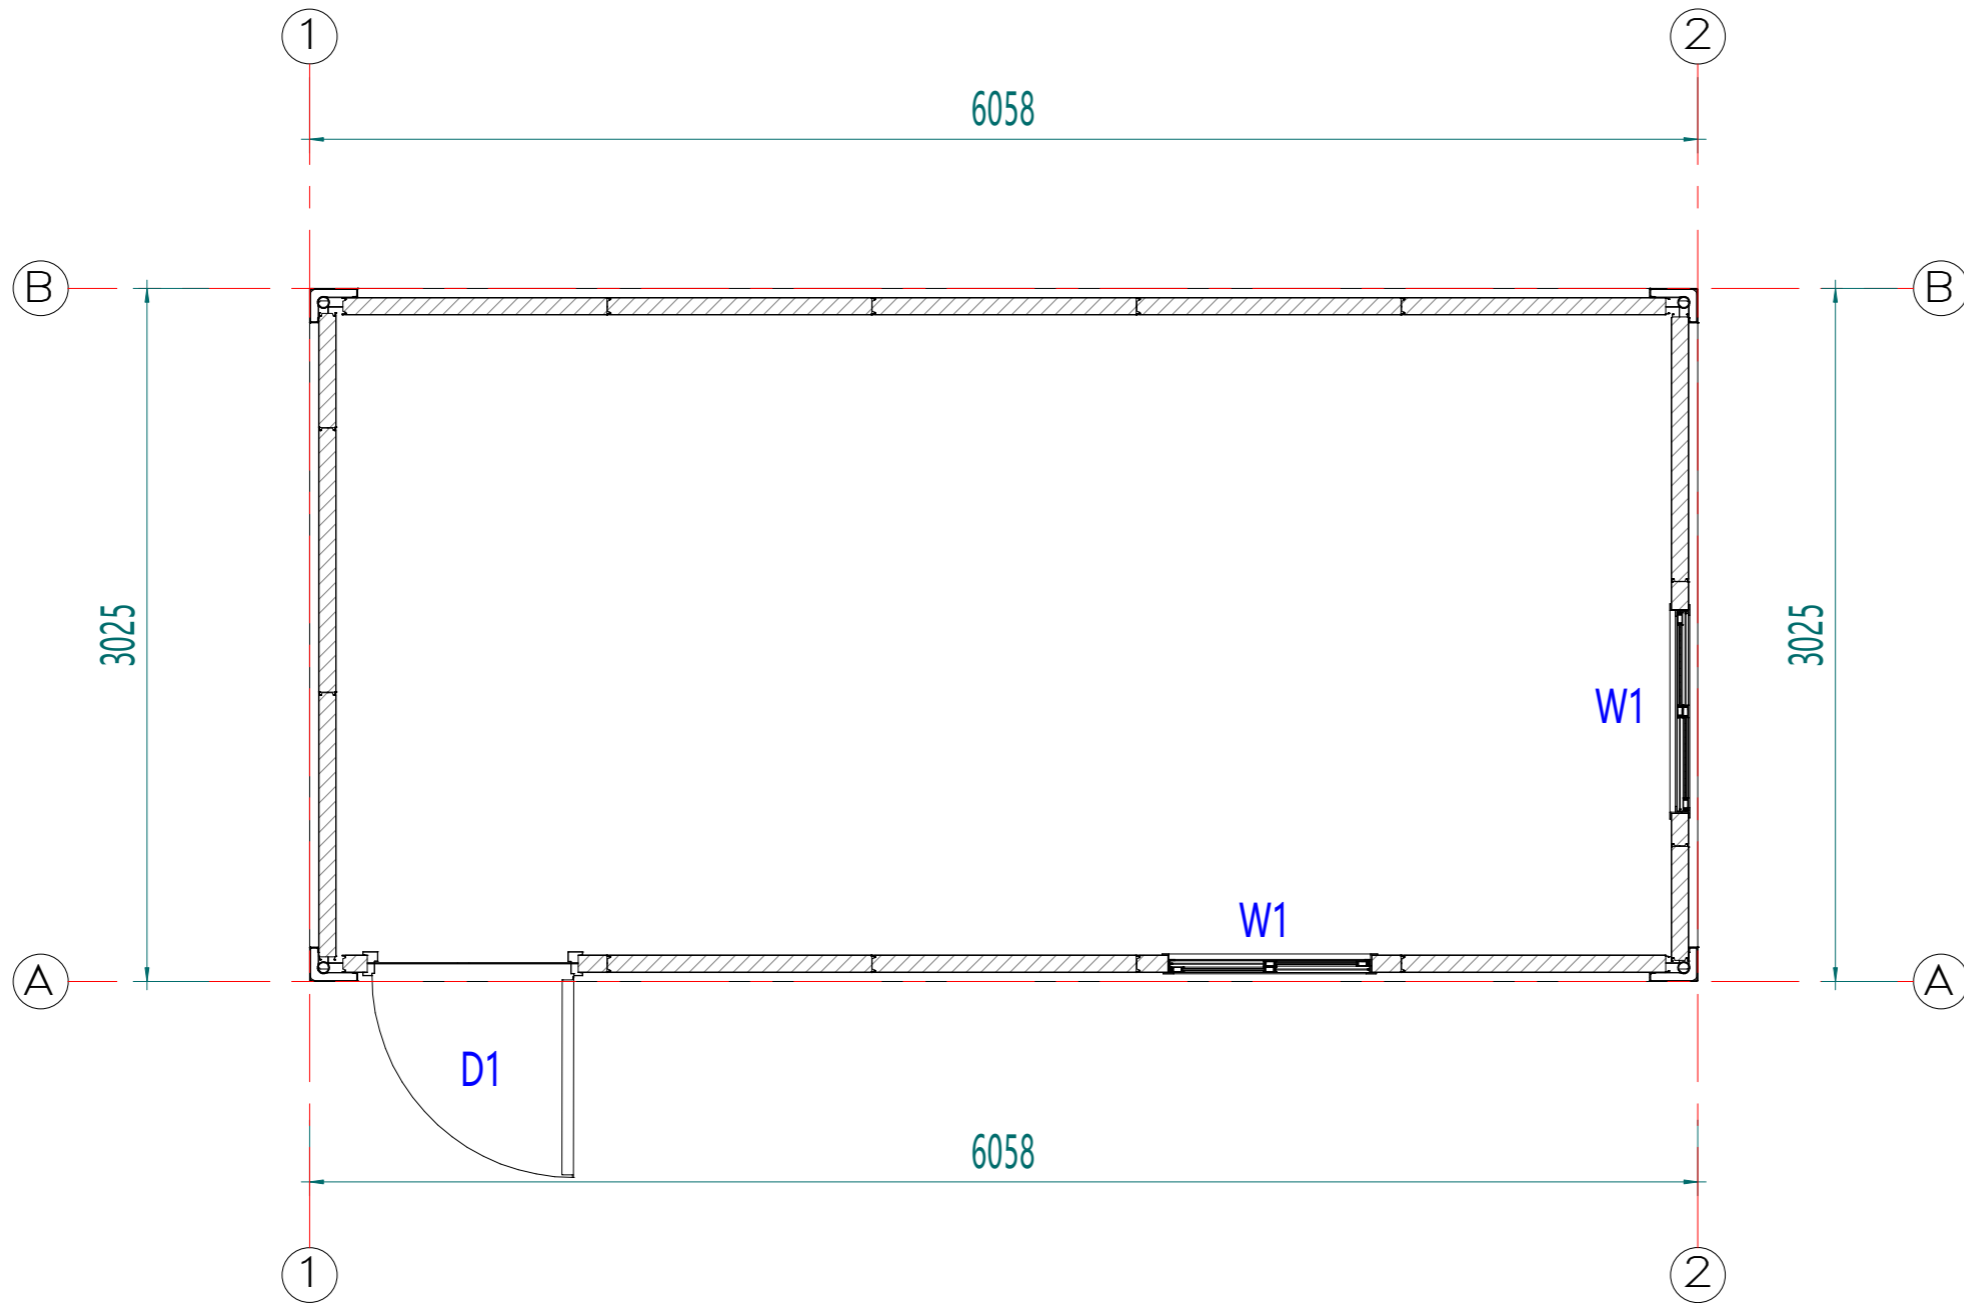

LAYOUT PLAN

Copyright 2016.
 本图版权归浙江普天集成房屋有限公司所有，除本工程外对本图的任何其它用途和复制，
 必须获得本公司的书面许可。
 THE OWNERSHIP OF THE COPYRIGHT IN THIS DRAWING IS RETAINED BY
 ZHEJIANG PUTIAN INTEGRATED HOUSING CO.LTD. WRITTEN CONSENT MUST BE
 OBTAINED BEFORE ANY USE OR REPRODUCTION OF THE DRAWING.

版本	修改内容	日期	发布人
Rev.	Description	Date	who send



Zhejiang Putian integrated housing Co., Ltd.
 Hangzhou Zhongpu Architecture Design (institute) Co., Ltd.

证书等级	
证书编号	

合作设计单位
 Cooperative Designer

工序	签名	日期
Process	Signature	Date
审定		
Authorized By		
审核		
Verified By		
项目负责人		
Process		
校对人		
Checked By		
设计	LHB	
Designed By		
制图	LHB	
Drawn By		

执业签章
 Engineer Signature

出图签章
 Engineer Signature





项目名称
 Project Name
 澳大利亚-集装箱

图名
 Title
 平面布置图

工程编号	PT221046-1	专业	JZ
比例		图号	J0-1

未盖技术出图章本图纸无效
 This drawing is void only after being stamped and
 released by the staff.

电力	暖通	动力
建筑	结构	给排水
会签		

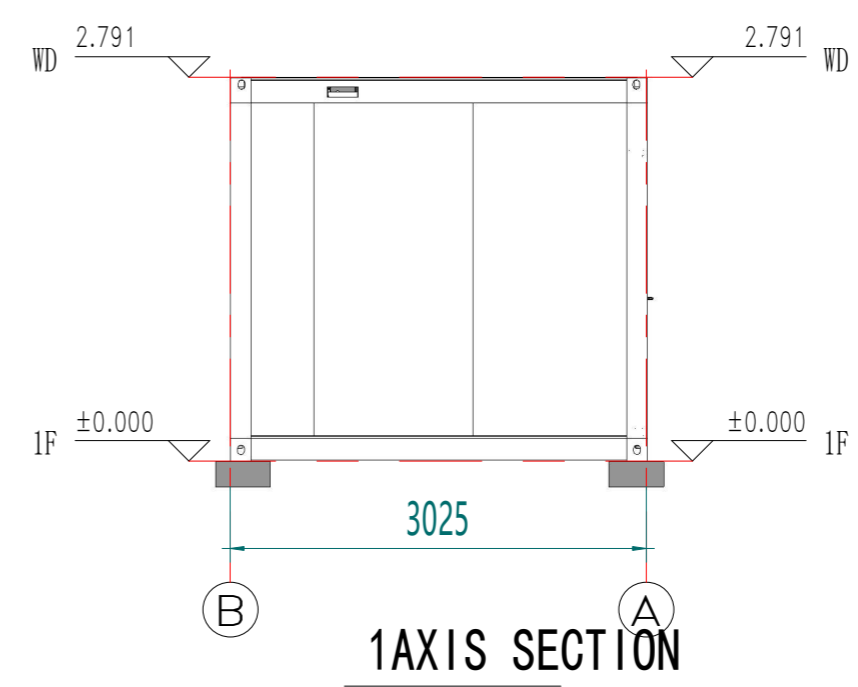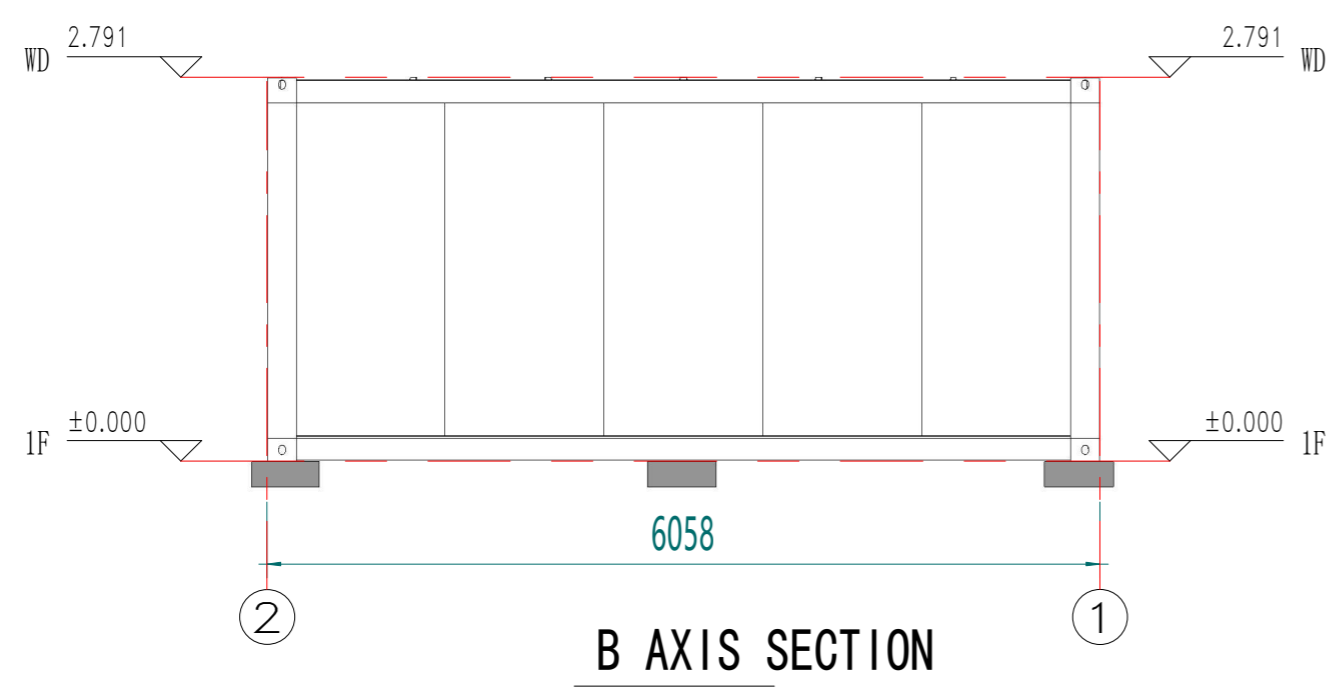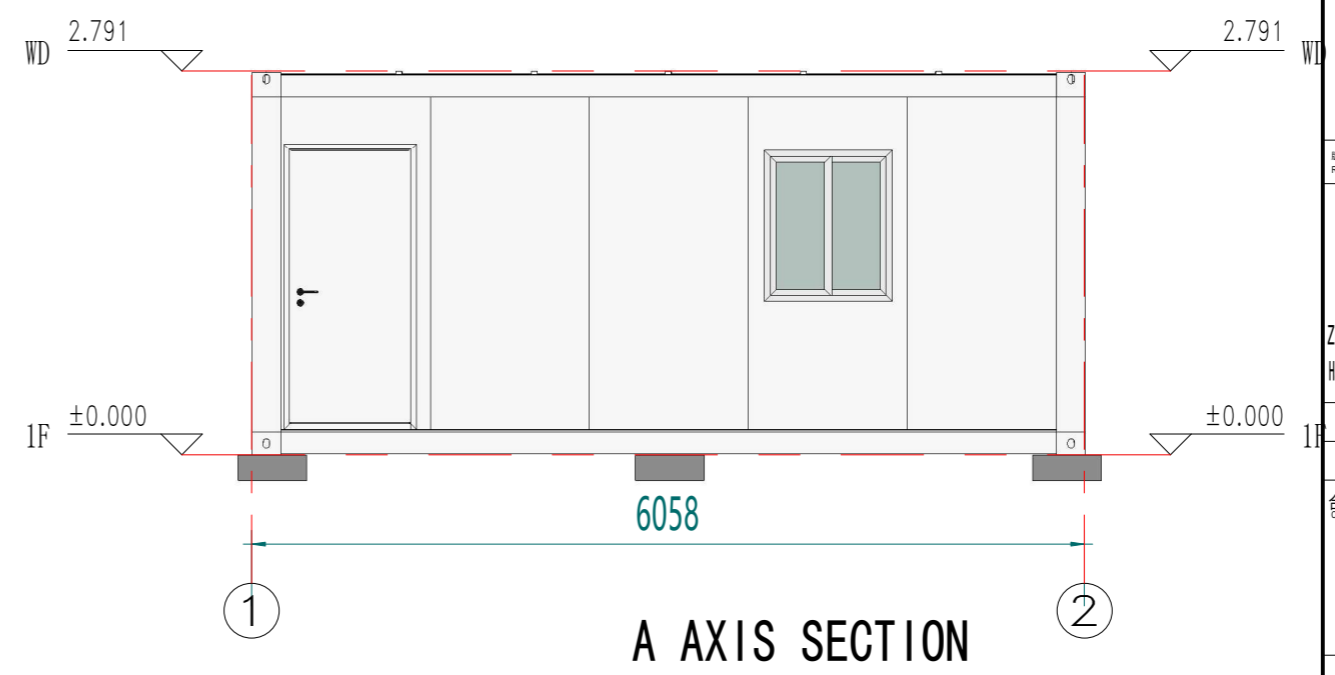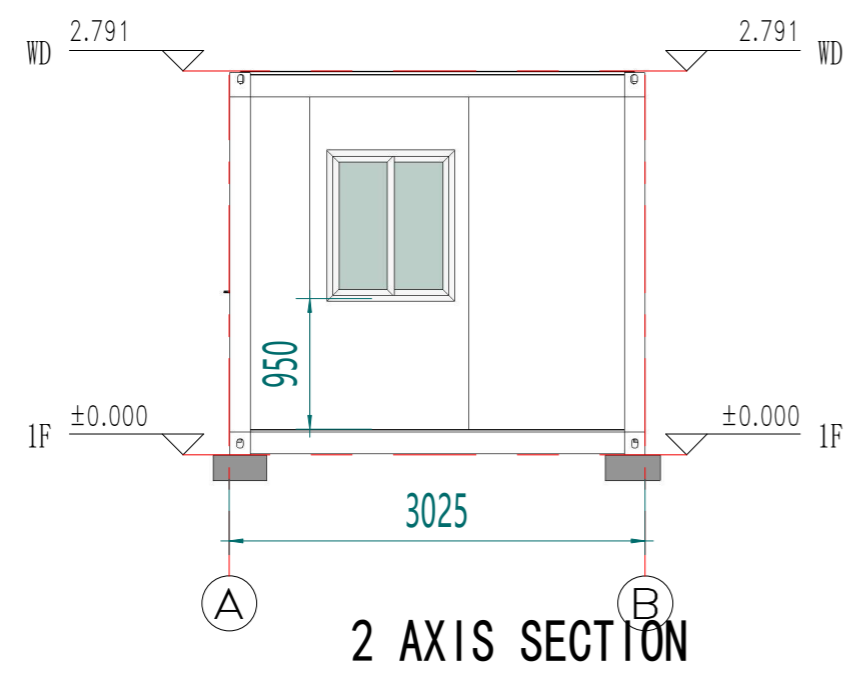

Copyright 2016.
 本图版权归浙江普天集成房屋有限公司所有，除本工程外对本图的任何其他用途和复制，
 必须获得本公司的书面许可。
 THE OWNERSHIP OF THE COPYRIGHT IN THIS DRAWING IS RESTRICTED BY
 ZHEJIANG PUTIAN INTEGRATED HOUSING CO.,LTD. WRITTEN CONSENT MUST BE
 OBTAINED BEFORE ANY USE OR REPRODUCTION OF THE DRAWING.

Rev.	修改内容 Description	日期 Date	发布人 who send
------	---------------------	------------	-----------------



Zhejiang Putian integrated housing Co., Ltd.
 Hangzhou Zhongpu Architecture Design (institute) Co., Ltd.

证书等级	
证书编号	
合作设计单位 Cooperative Designer	

工序 Process	签名 Signature	日期 Date
审定 Authorized By		
审核 Verified By		
项目负责人 Process		
校对人 Checked By		
设计 Designed By	LHB	
制图 Drawn By	LHB	

执业签章
Engineer Signature

出图签章
Engineer Signature


项目名称
Project Name
澳大利亚·集装箱

图名
Title
立面布置图

工程编号 No.	PT221046-1	专业 Discipline	JZ
比例 Scale		图号 Drawing No.	J0-2

未盖技术出图章本图纸无效
 This drawing is void only after being stamped and
 released by the client.

电力	暖通	动力
建筑	结构	给排水
会签		

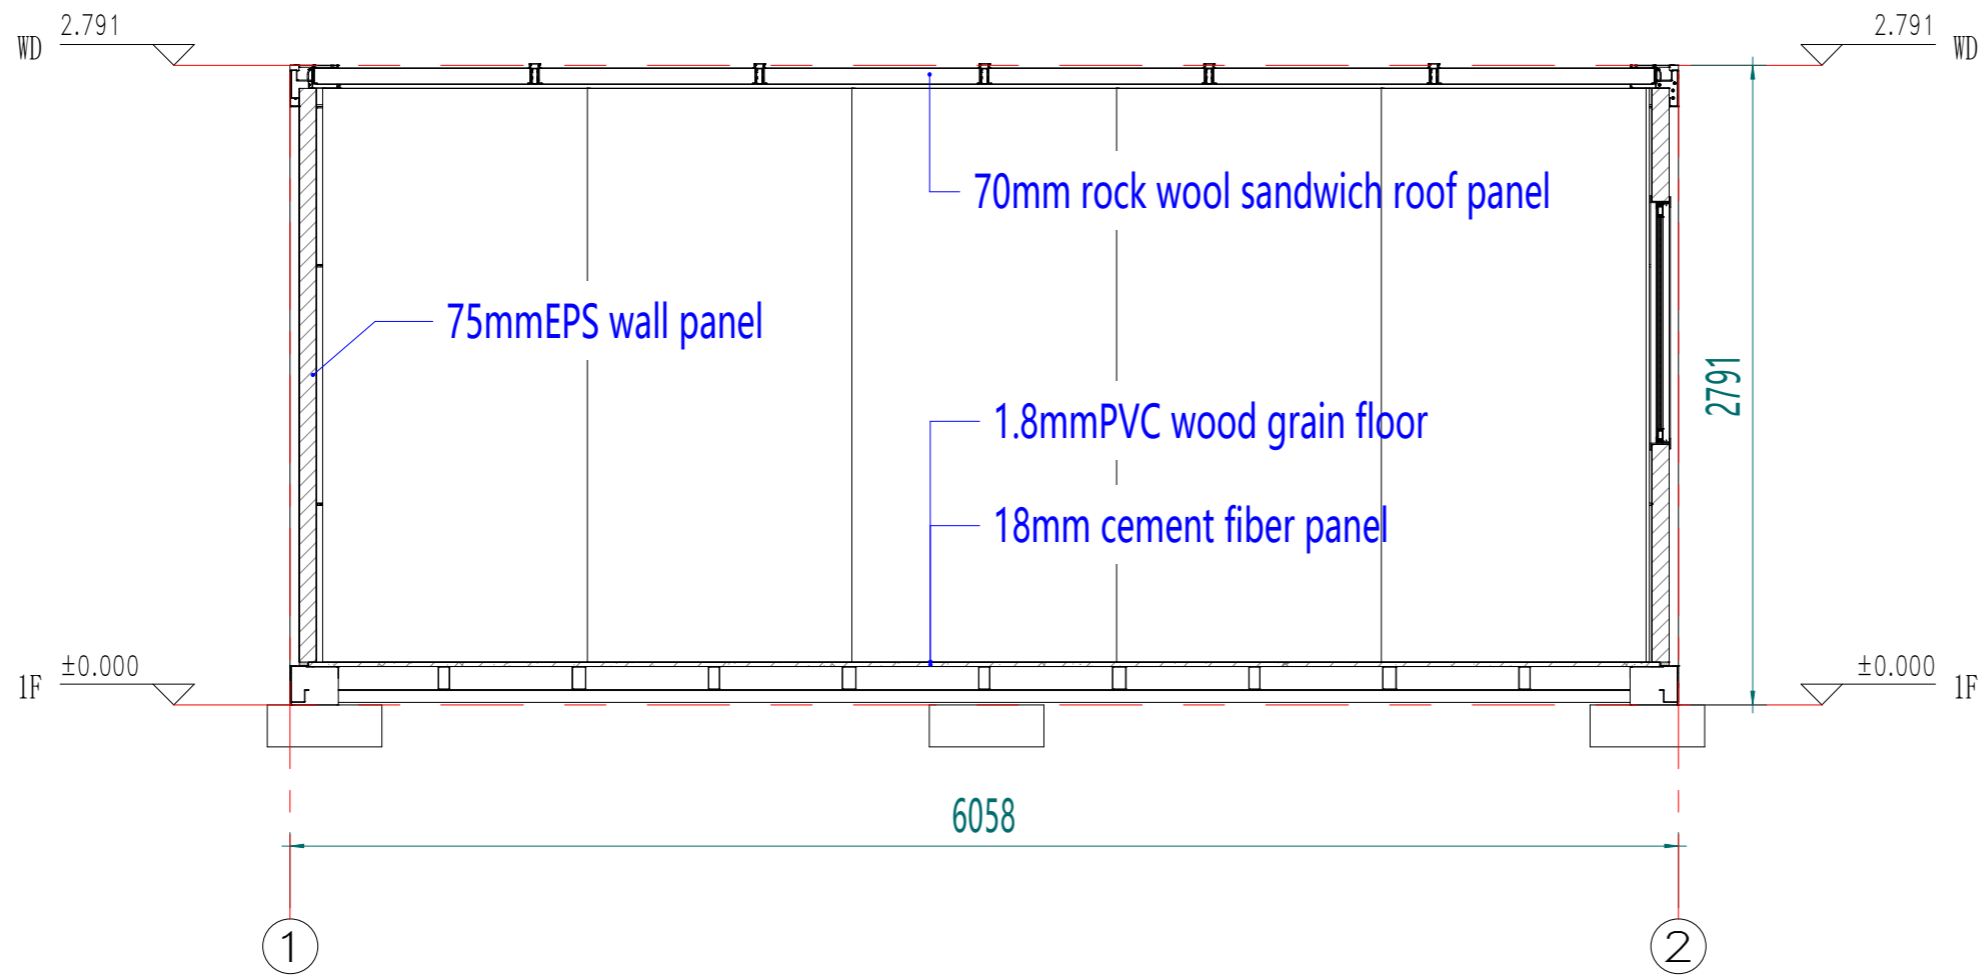

Copyright 2016.
 本图版权归浙江普天集成房屋有限公司所有，除本工程外对本图的任何其它用途和复制，
 必须获得本公司的书面许可。
 THE OWNERSHIP OF THE COPYRIGHT IN THIS DRAWING IS RESTRICTED BY
 ZHEJIANG PUTIAN INTEGRATED HOUSING CO.LTD. WRITTEN CONSENT MUST BE
 OBTAINED BEFORE ANY USE OR REPRODUCTION OF THE DRAWING.

Rev.	修改内容 Description	日期 Date	发布人 who send
------	---------------------	------------	-----------------



Zhejiang Putian integrated housing Co., Ltd.
 Hangzhou Zhongpu Architecture Design (institute) Co., Ltd.

证书等级	
证书编号	
合作设计单位 Cooperative Designer	

工序 Process	签名 Signature	日期 Date
审定 Authorized By		
审核 Verified By		
项目负责人 Process		
校对 Checked By		
设计 Designed By	LHB	
制图 Drawn By	LHB	

执业签章
Engineer Signature

出图签章
Engineer Signature


项目名称
Project Name
澳大利亚·集装箱

图名
Title
剖面布置图

工程编号 No.	PT221046-1	专业 Spec.	JZ
比例 Scale		图号 No.	J0-3

未盖技术出图章 本图纸无效
 This drawing is void only after being stamped and released by the main.


电力	暖通	动力
建筑	结构	给排水
会签		

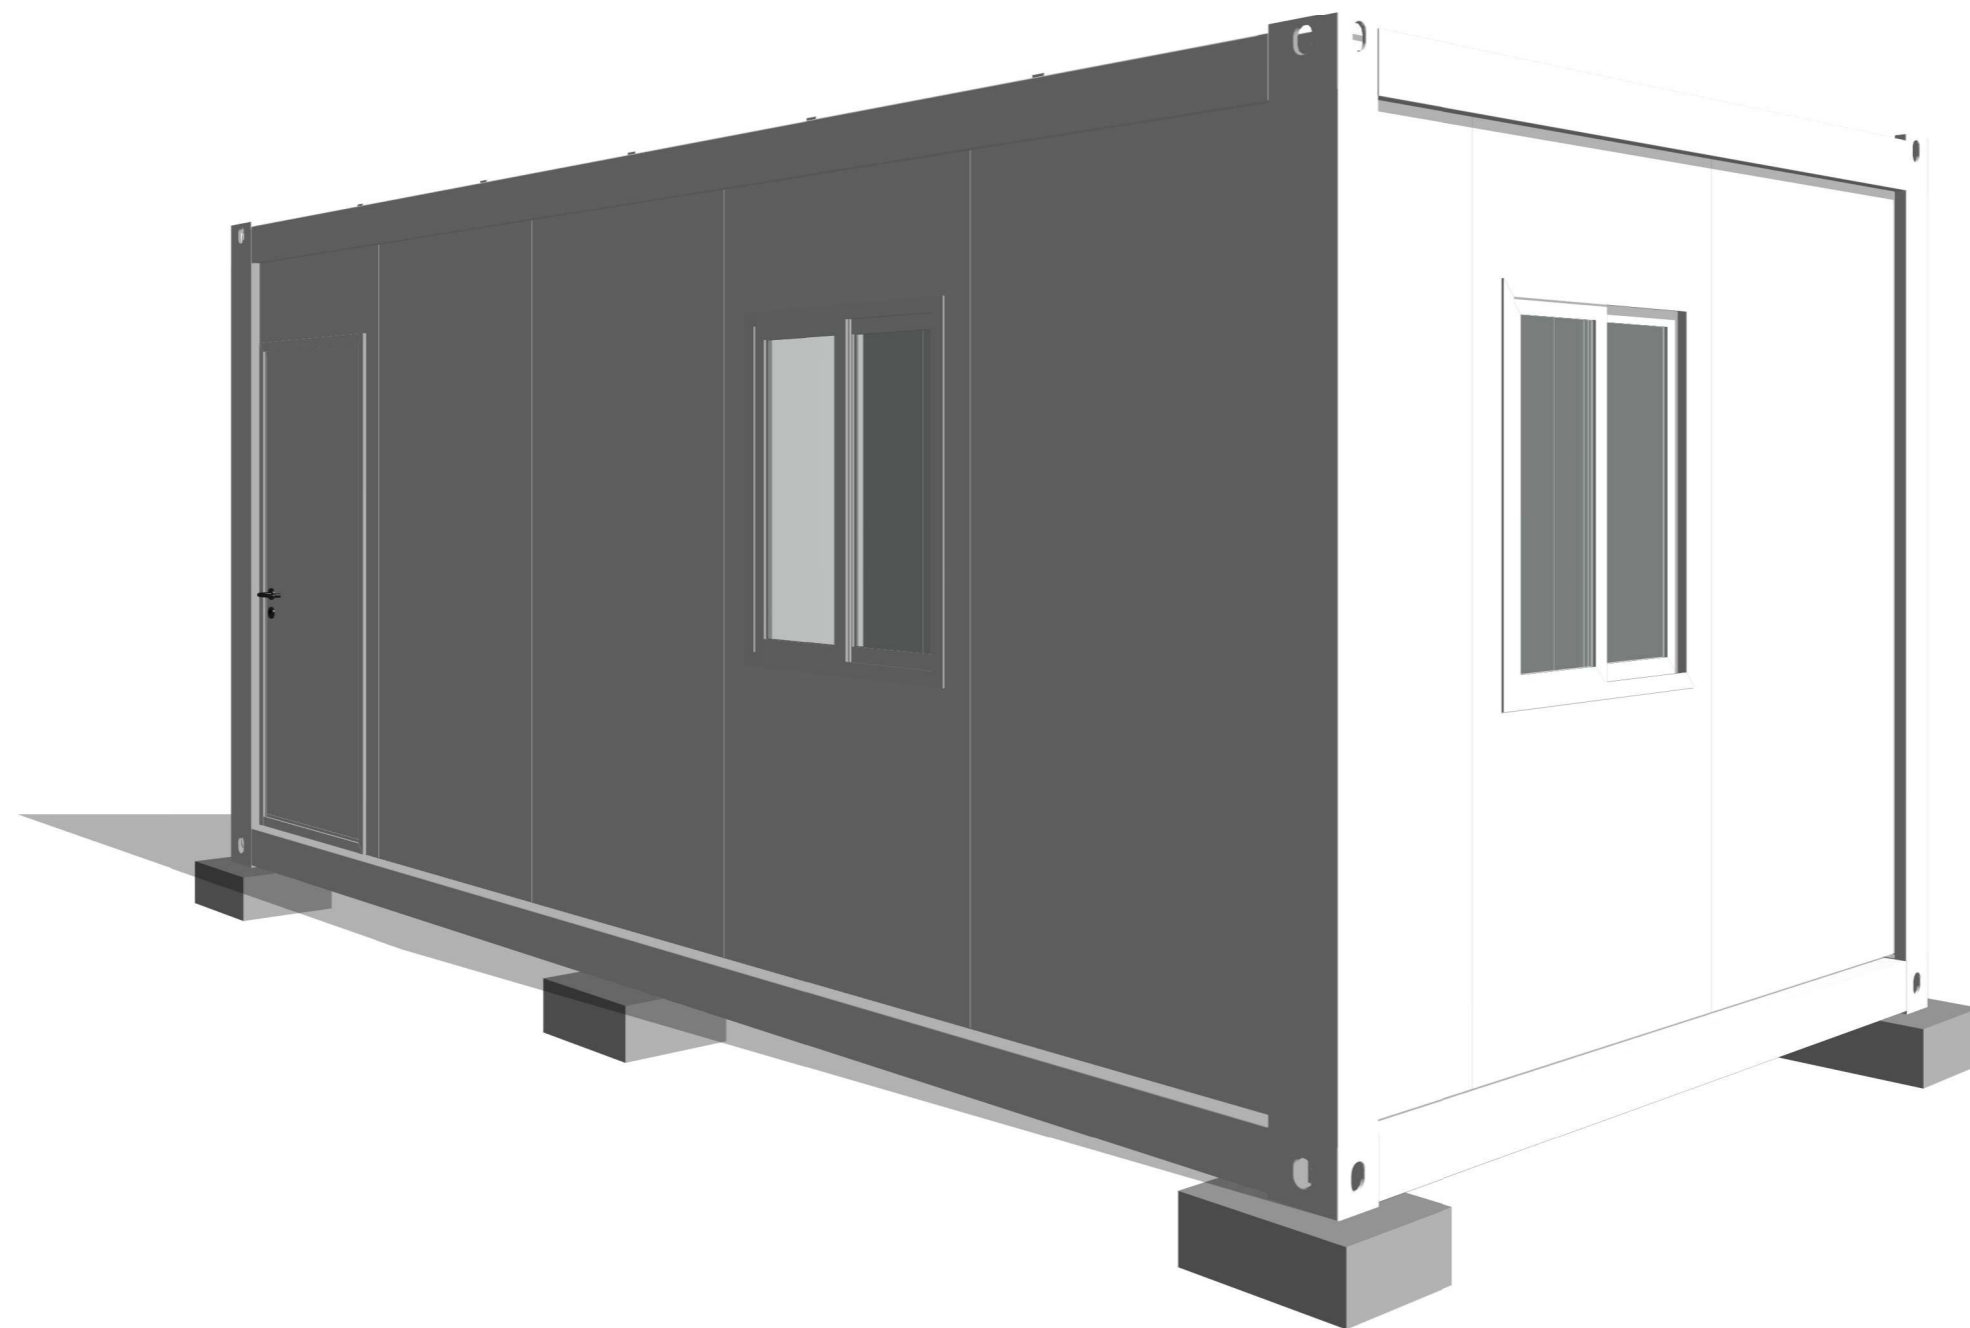

注：颜色仅供参考，具体颜色按照订单备注或者样品为准

Copyright 2016.			
本图版权归浙江普天集成房屋有限公司所有，除本工程外对本图的任何其它用途均受限制。 必须获得本公司的书面许可。 THE OWNERSHIP OF THE COPYRIGHT IN THIS DRAWING IS RETAINED BY ZHEJIANG PUTIAN INTEGRATED HOUSING CO.LTD. WRITTEN CONSENT MUST BE OBTAINED BEFORE ANY USE OR REPRODUCTION OF THE DRAWING.			
版本 Rev.	修改内容 Description	日期 Date	发布人 who send
			
Zhejiang Putian integrated housing Co., Ltd. Hangzhou Zhongpu Architecture Design (institute) Co., Ltd.			
证书等级			
证书编号			
合作设计单位 Cooperative Designer			
工序 Process	签名 Signature	日期 Date	
审定 Authorized By			
审核 Verified By			
项目负责人 Process			
校对 Checked By			
设计 Designed By	LHB		
制图 Drawn By	LHB		
执业签章 Engineer Signature			
出图签章 Engineer Signature			
项目名称 Project Name	澳大利亚-集装箱		
图名 Title	三维视图		
工程编号 No.	PT221046-1	专业 Res	JZ
比例		图号	J0-4
未盖技术出图章本图纸无效			
This drawing is valid only after being stamped and released by the main.			


电力	暖通	动力
建筑	结构	给排水
会签		

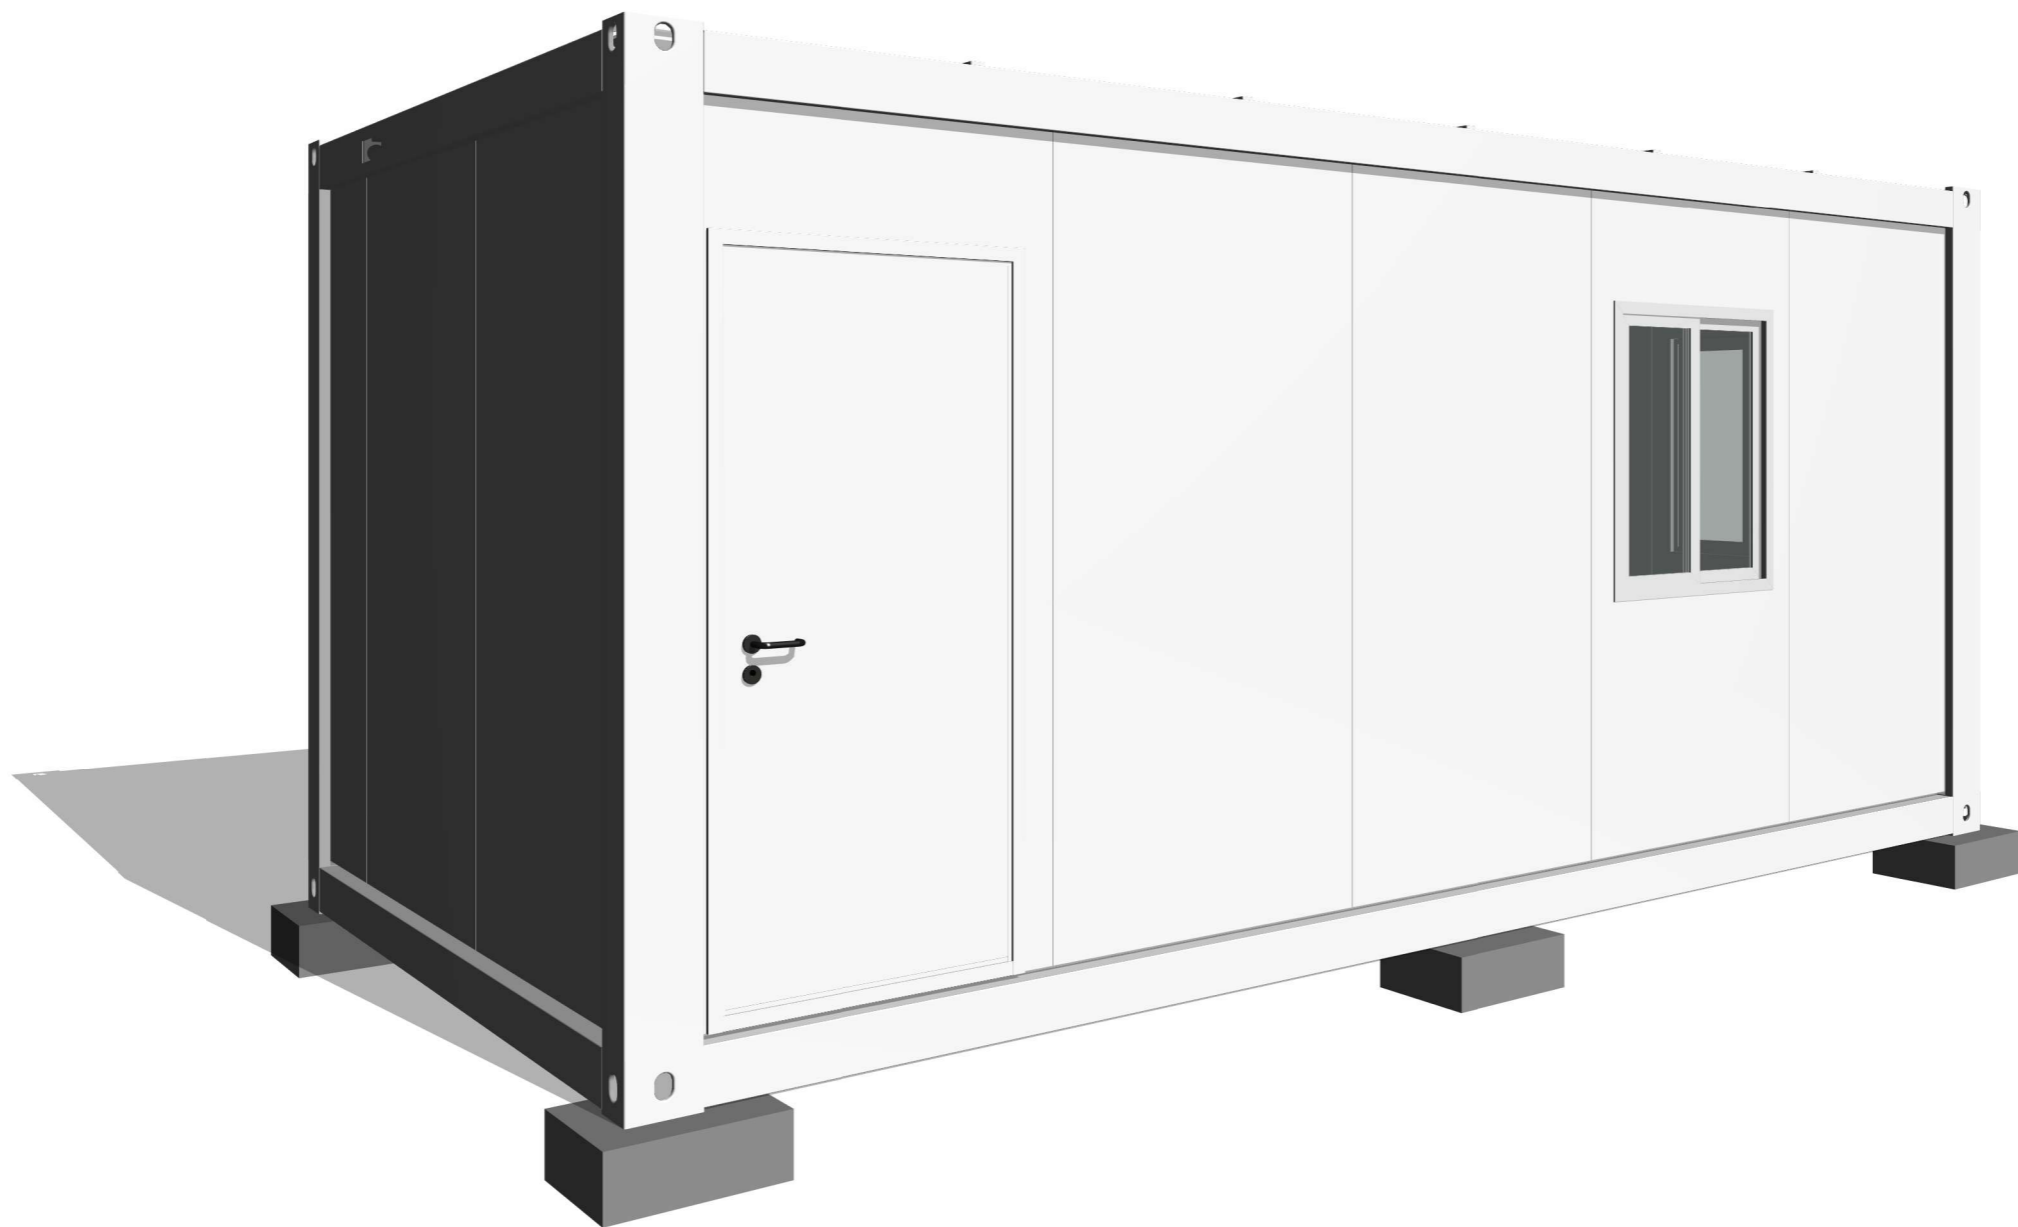

注：颜色仅供参考，具体颜色按照订单备注或者样品为准

Copyright 2016. <small>本图版权归浙江普天集成房屋有限公司所有，除本工程外对本图的任何其它用途均受限制。 THE OWNERSHIP OF THE COPYRIGHT IN THIS DRAWING IS RETAINED BY ZHEJIANG PUTIAN INTEGRATED HOUSING CO.,LTD. WRITTEN CONSENT MUST BE OBTAINED BEFORE ANY USE OR REPRODUCTION OF THE DRAWING.</small>			
版本 Rev.	修改内容 Description	日期 Date	发布人 who send
 Zhejiang Putian integrated housing Co., Ltd. Hangzhou Zhongpu Architecture Design (institute) Co., Ltd.			
证书等级			
证书编号			
合作设计单位 Cooperative Designer			
工序 Process	签名 Signature	日期 Date	
审定 Authorized By			
审核 Verified By			
项目负责人 Process			
校对 Checked By			
设计 Designed By	LHB		
制图 Drawn By	LHB		
执业签章 Engineer Signature			
出图签章 Engineer Signature			
项目名称 Project Name	澳大利亚-集装箱		
图名 Title	三维视图		
工程编号 No.	PT221046-1	专业 Res.	JZ
比例		图号	J0-5
未盖技术出图章 本图纸无效 <small>This drawing is valid only after being stamped and released by the main.</small>			

电力	暖通	动力
建筑	结构	给排水
会签		

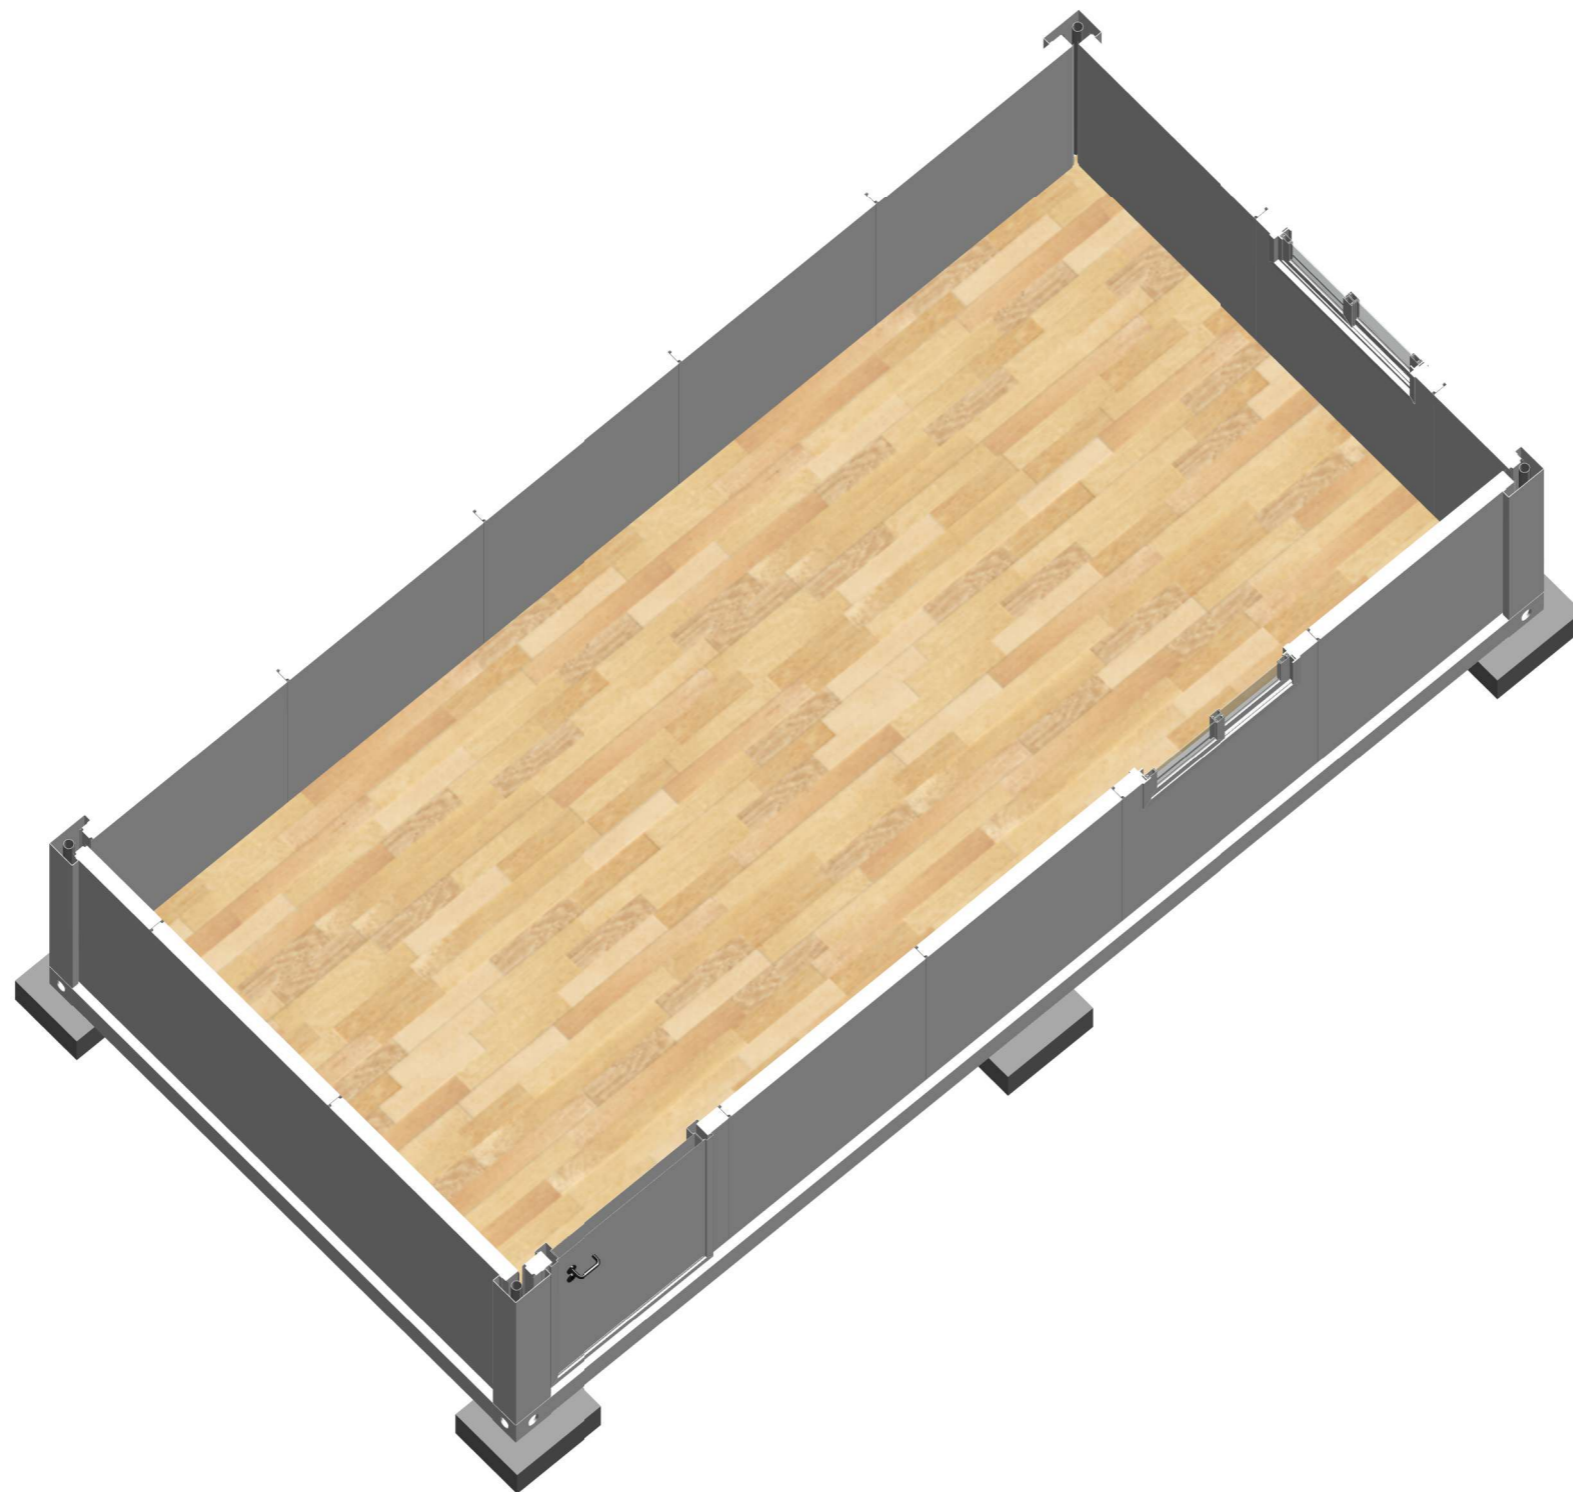


3D View

注：颜色仅供参考，具体颜色按照订单备注或者样品为准

Copyright 2016. 本图版权归浙江普天集成房屋有限公司所有，除本工程外对本图的任何其它用途和复制， 必须获得本公司的书面许可。 THE OWNERSHIP OF THE COPYRIGHT IN THIS DRAWING IS RESTRICTED BY ZHEJIANG PUTIAN INTEGRATED HOUSING CO.LTD. WRITTEN CONSENT MUST BE OBTAINED BEFORE ANY USE OR REPRODUCTION OF THE DRAWING.			
版本 Rev.	修改内容 Description	日期 Date	发布人 who send
 Zhejiang Putian integrated housing Co., Ltd. Hangzhou Zhongpu Architecture Design (institute) Co., Ltd.			
证书等级			
证书编号			
合作设计单位 Cooperative Designer			
工序 Process	签名 Signature	日期 Date	
审定 Authorized By			
审核 Verified By			
项目负责人 Process			
校对 Checked By			
设计 Designed By	LHB		
制图 Drawn By	LHB		
执业签章 Engineer Signature			
出图签章 Engineer Signature			
项目名称 Project Name	澳大利亚-集装箱		
图名 Title	三维剖视		
工程编号 No.	PT221046-1	专业 Discipline	JZ
比例 Scale		图号 Drawing No.	J0-6
未盖技术出图章 本图纸无效 <small>This drawing is valid only after being stamped and released by the client.</small>			

电力	暖通	动力
建筑	结构	给排水
会	签	

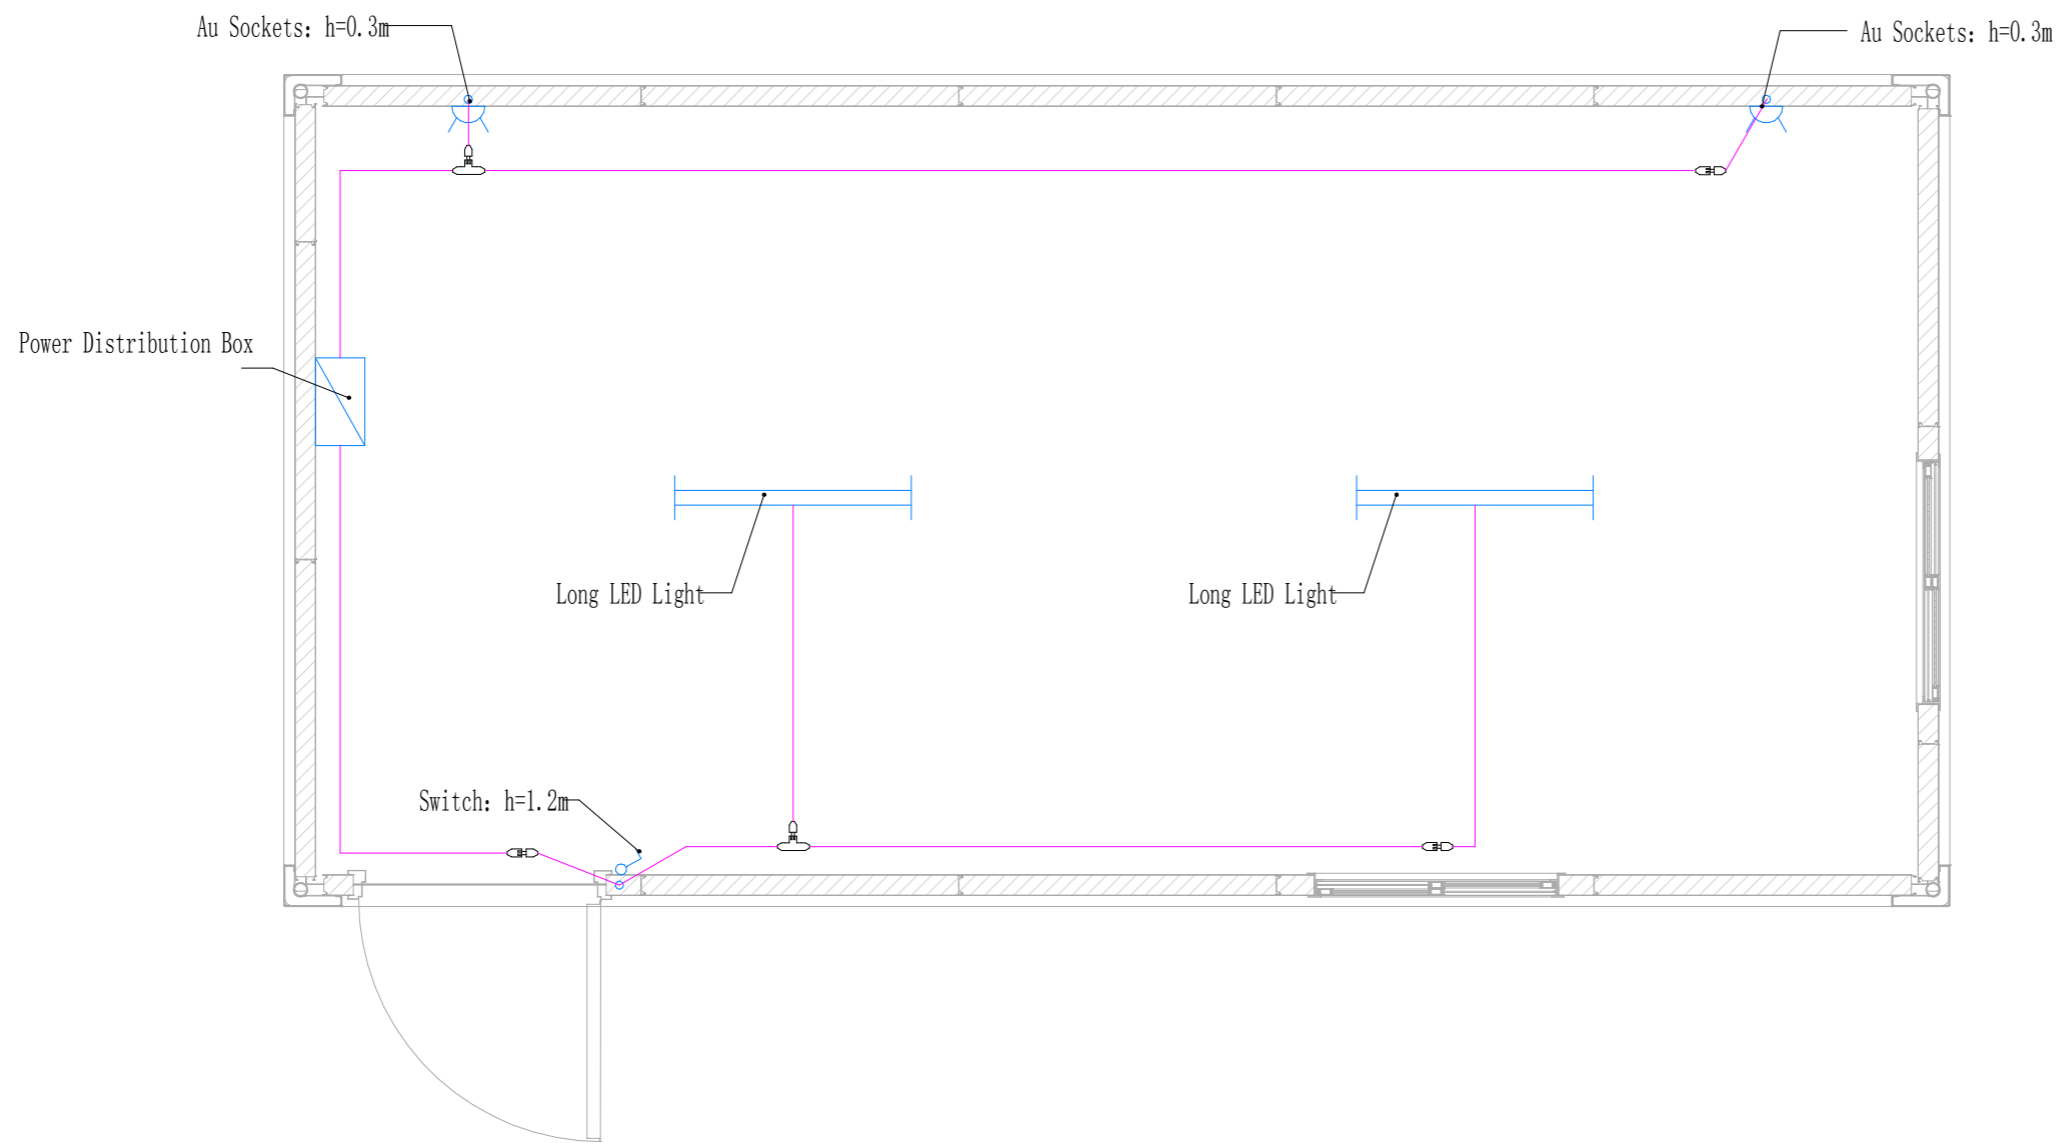

Electrical plan

Copyright 2016.
 本图版权归浙江普天集成房屋有限公司所有，除本工程外对本图的任何其它用途和复制，
 必须获得本公司的书面许可。
 THE OWNERSHIP OF THE COPYRIGHT IN THIS DRAWING IS RESTRICTED BY
 ZHEJIANG PUTIAN INTEGRATED HOUSING CO.LTD. WRITTEN CONSENT MUST BE
 OBTAINED BEFORE ANY USE OR REPRODUCTION OF THE DRAWING.

版本	修改内容	日期	发布人
Rev.	Description	Date	who send



Zhejiang Putian integrated housing Co., Ltd.
 Hangzhou Zhongpu Architecture Design (institute) Co., Ltd.

证书等级	
证书编号	
合作设计单位	Cooperative Designer

工序	签名	日期
Process	Signature	Date
审定		
Authorized By		
审核		
Verified By		
项目负责人		
Process		
校对		
Checked By		
设计	LHB	
Designed By		
制图	LHB	
Drawn By		

执业签章
 Engineer Signature

出图签章
 Engineer Signature

项目名称
 Project Name
 澳大利亚-集装箱

图名
 Title
 电力布置图

工程编号	PT221046-1	专业	JZ
比例		图号	J0-7

未盖技术出图章本图纸无效
 This drawing is valid only after being stamped and
 released by the main.